




SSI
Structural Solutions, Inc.
 Engineering Consultants
 1000 West Loop South, Suite 100
 Fort Worth, Texas 76102-3820
 817.569.0070 • 817.569.0075 FAX
 © COPYRIGHT 2008 BY STRUCTURAL SOLUTIONS, INC.

Date: 03/20/08
 Scale: As Shown
 Drawn: JSQ
 Job: 2006-05
 Sheet Number: S4.12


NEW WORSHIP FACILITIES & EDUCATION BUILDING
 EAST SIDE CHURCH OF CHRIST
 MLK @ HWY 183, AUSTIN, TEXAS

HALLUM ARCHITECTS, INC.
 6040 CAMP BOWIE BLVD SUITE 17
 FORT WORTH, TEXAS 76116
 PHONE: 817.332.2422 FAX: 817.338.1949
 email: info@hallumarch.com


Revisions:	
By:	

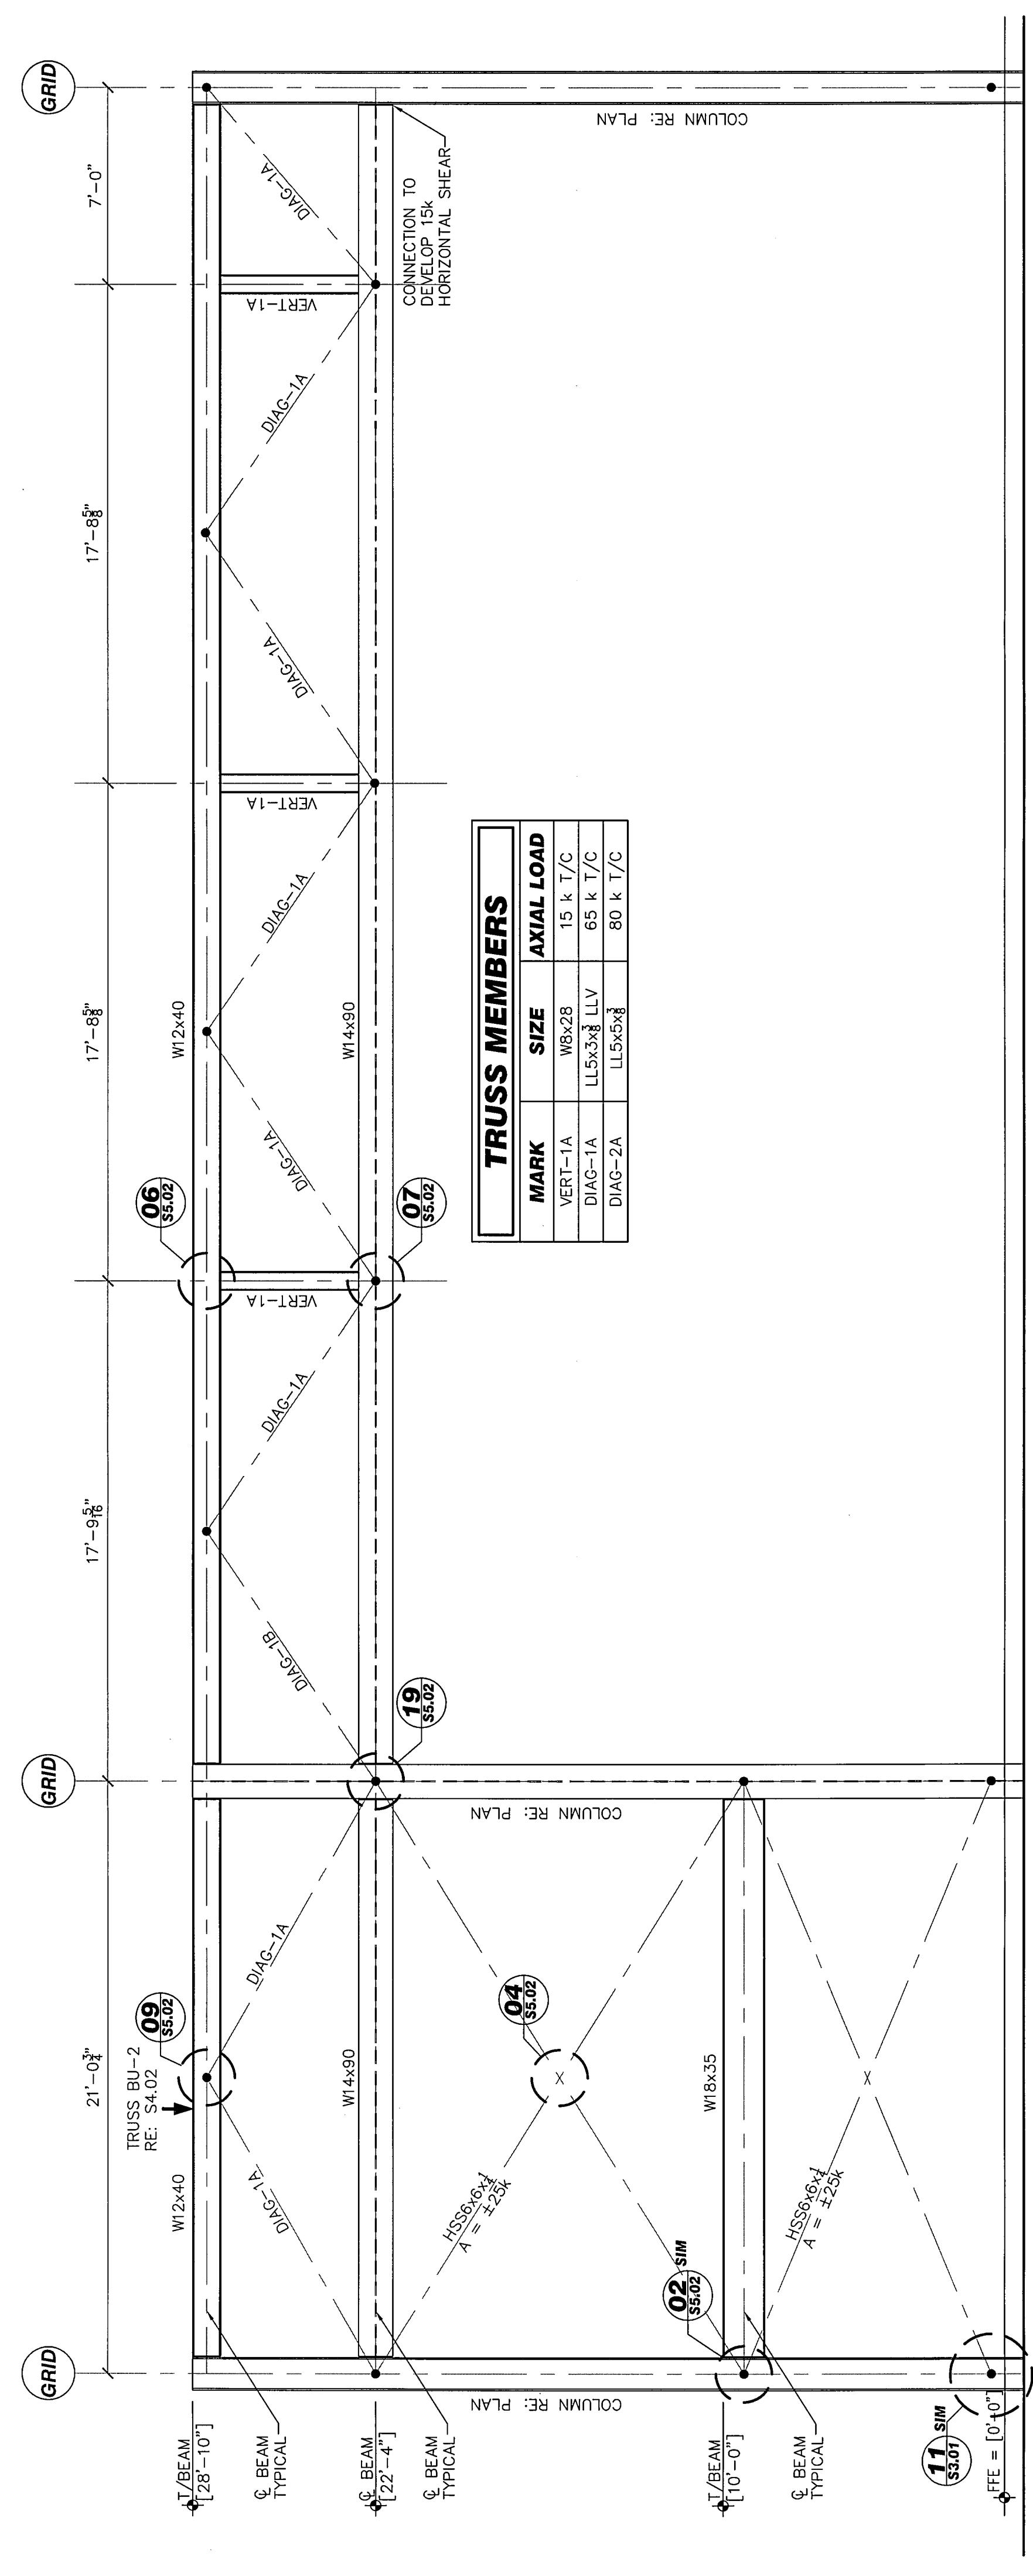

01 VERTICAL BRACE & MAIN TRUSS 1 ELEVATION
 NOT TO SCALE

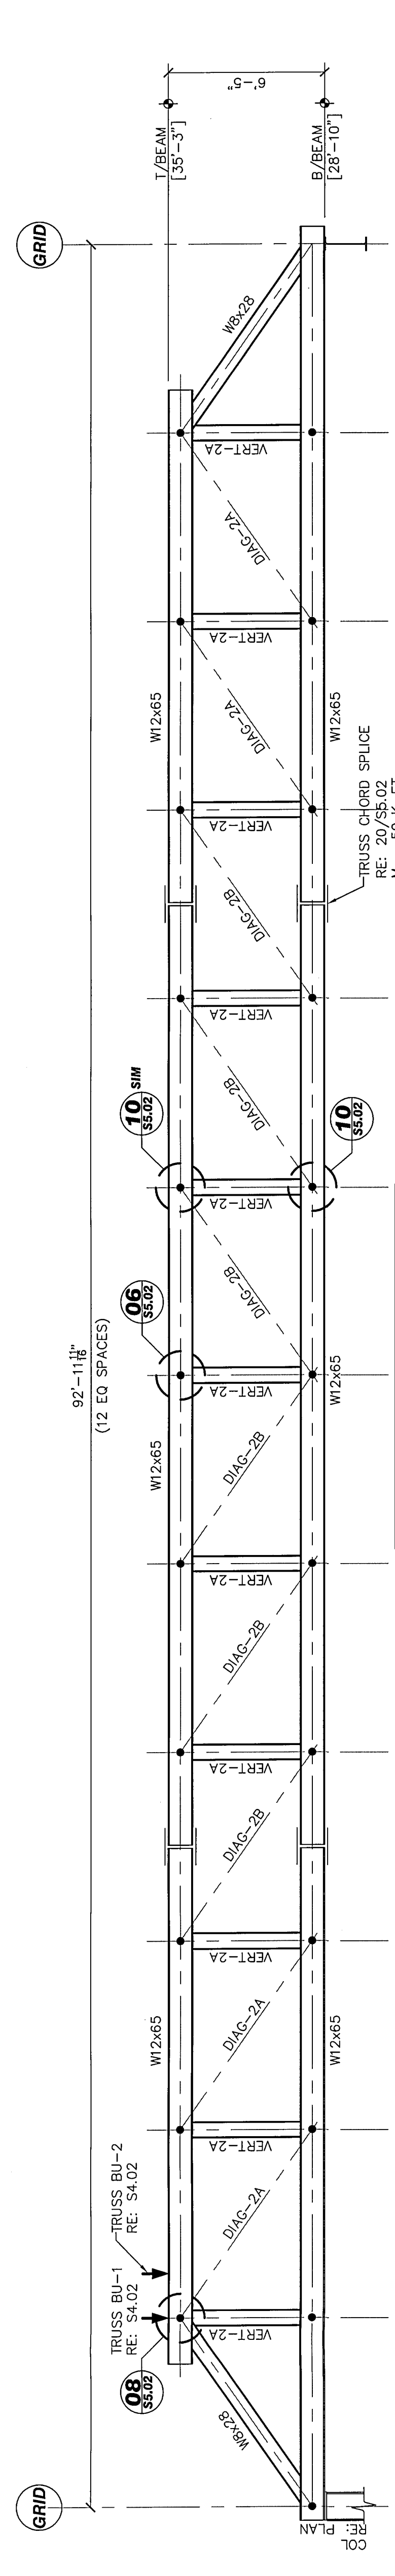

02 MAIN TRUSS 2 ELEVATION
 NOT TO SCALE

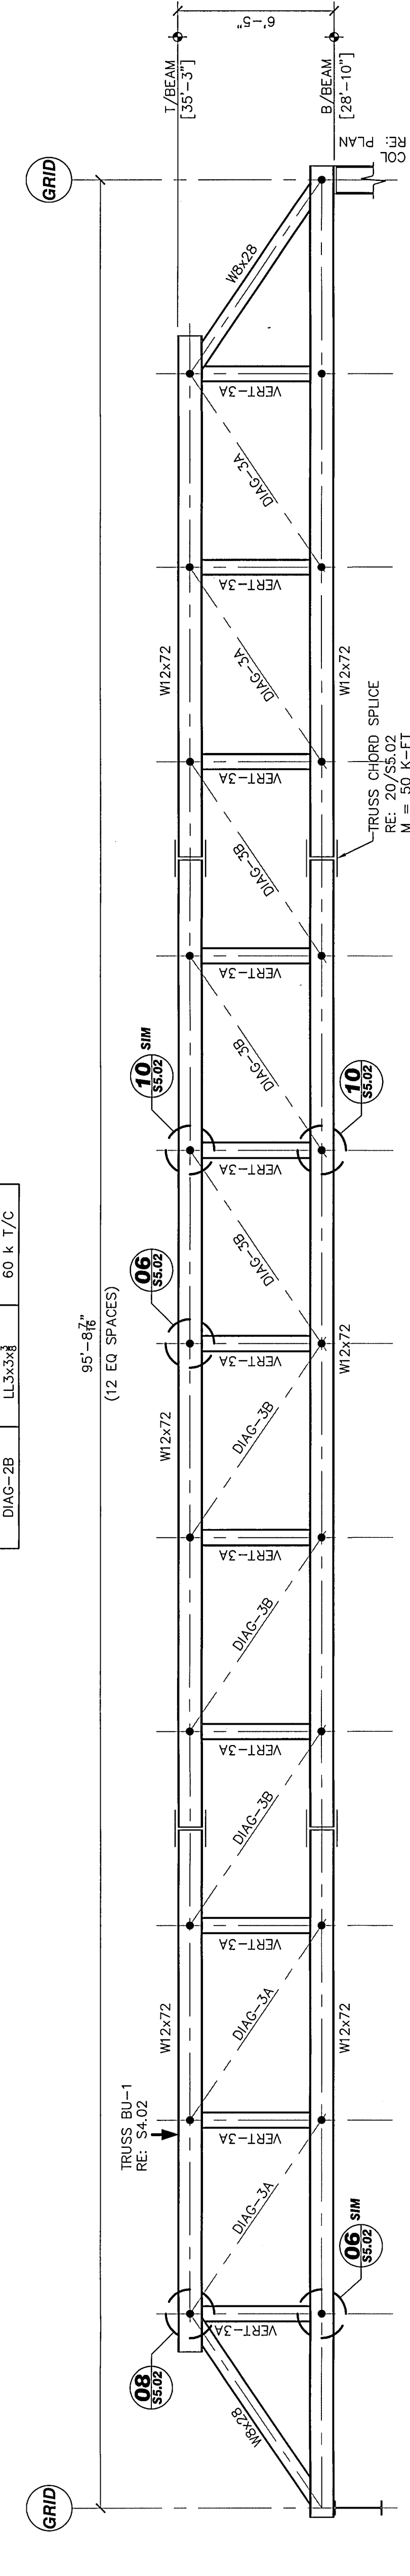

03 MAIN TRUSS 3 ELEVATION
 NOT TO SCALE